



EXISTING MAIN LIFT STATION  
ELECTRICAL FLOOR PLAN

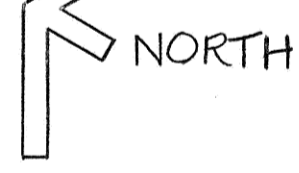


TO NEW MASTER PUMPING STATION

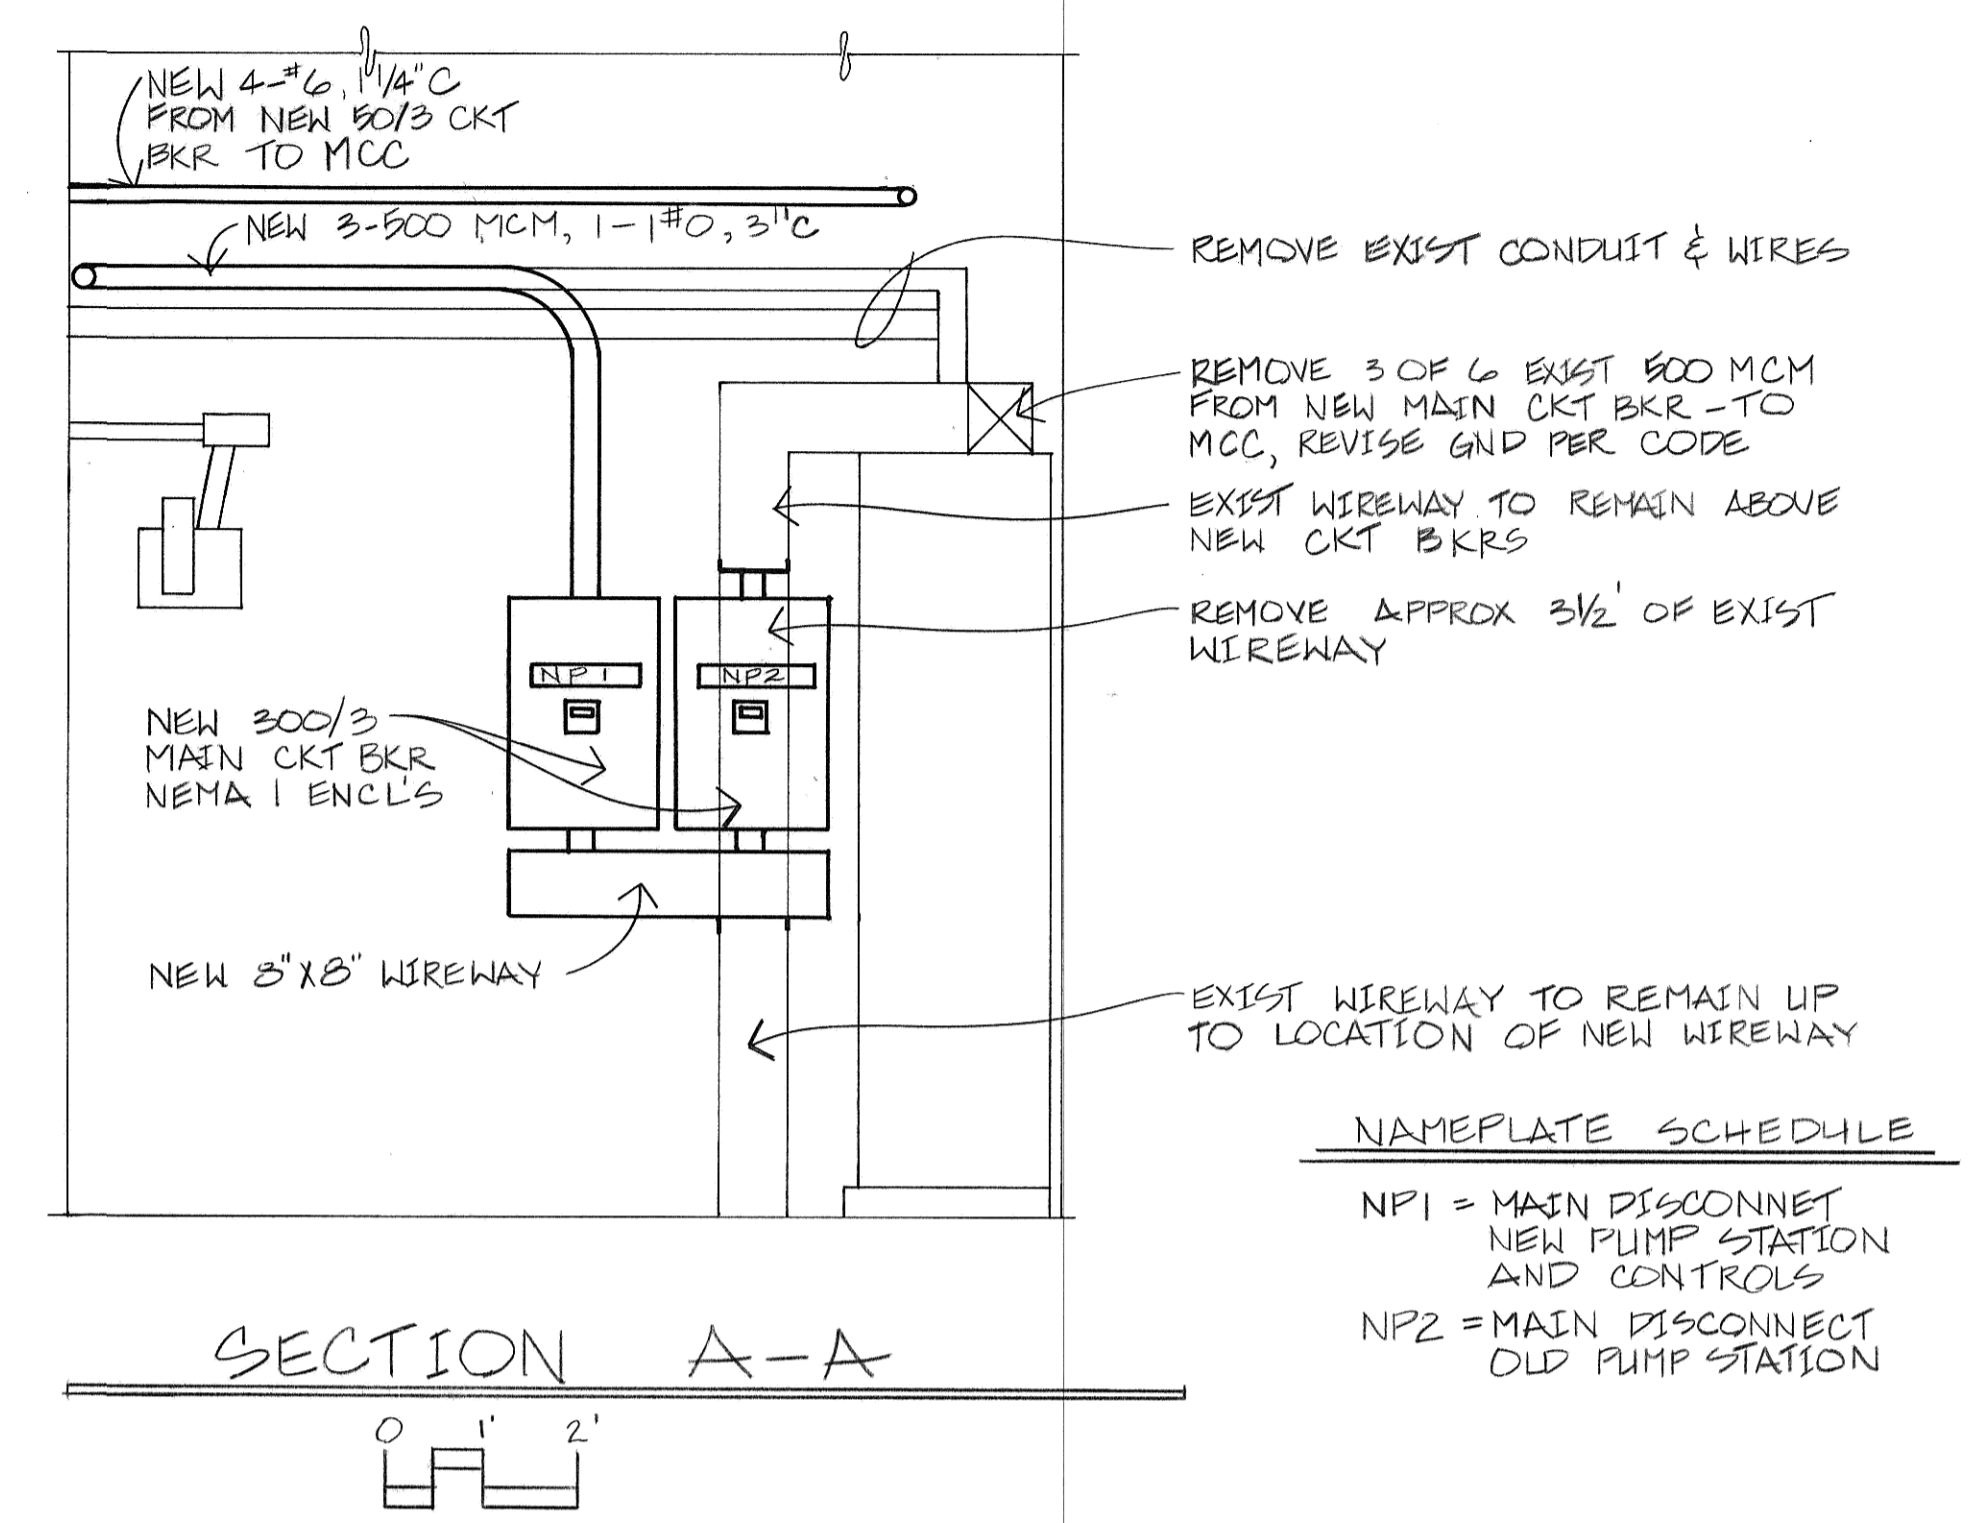

NAMEPLATE SCHEDULE

NP1	MAIN DISCONNECT NEW PUMP STATION AND CONTROLS
NP2	MAIN DISCONNECT OLD PUMP STATION

SECTION A-A

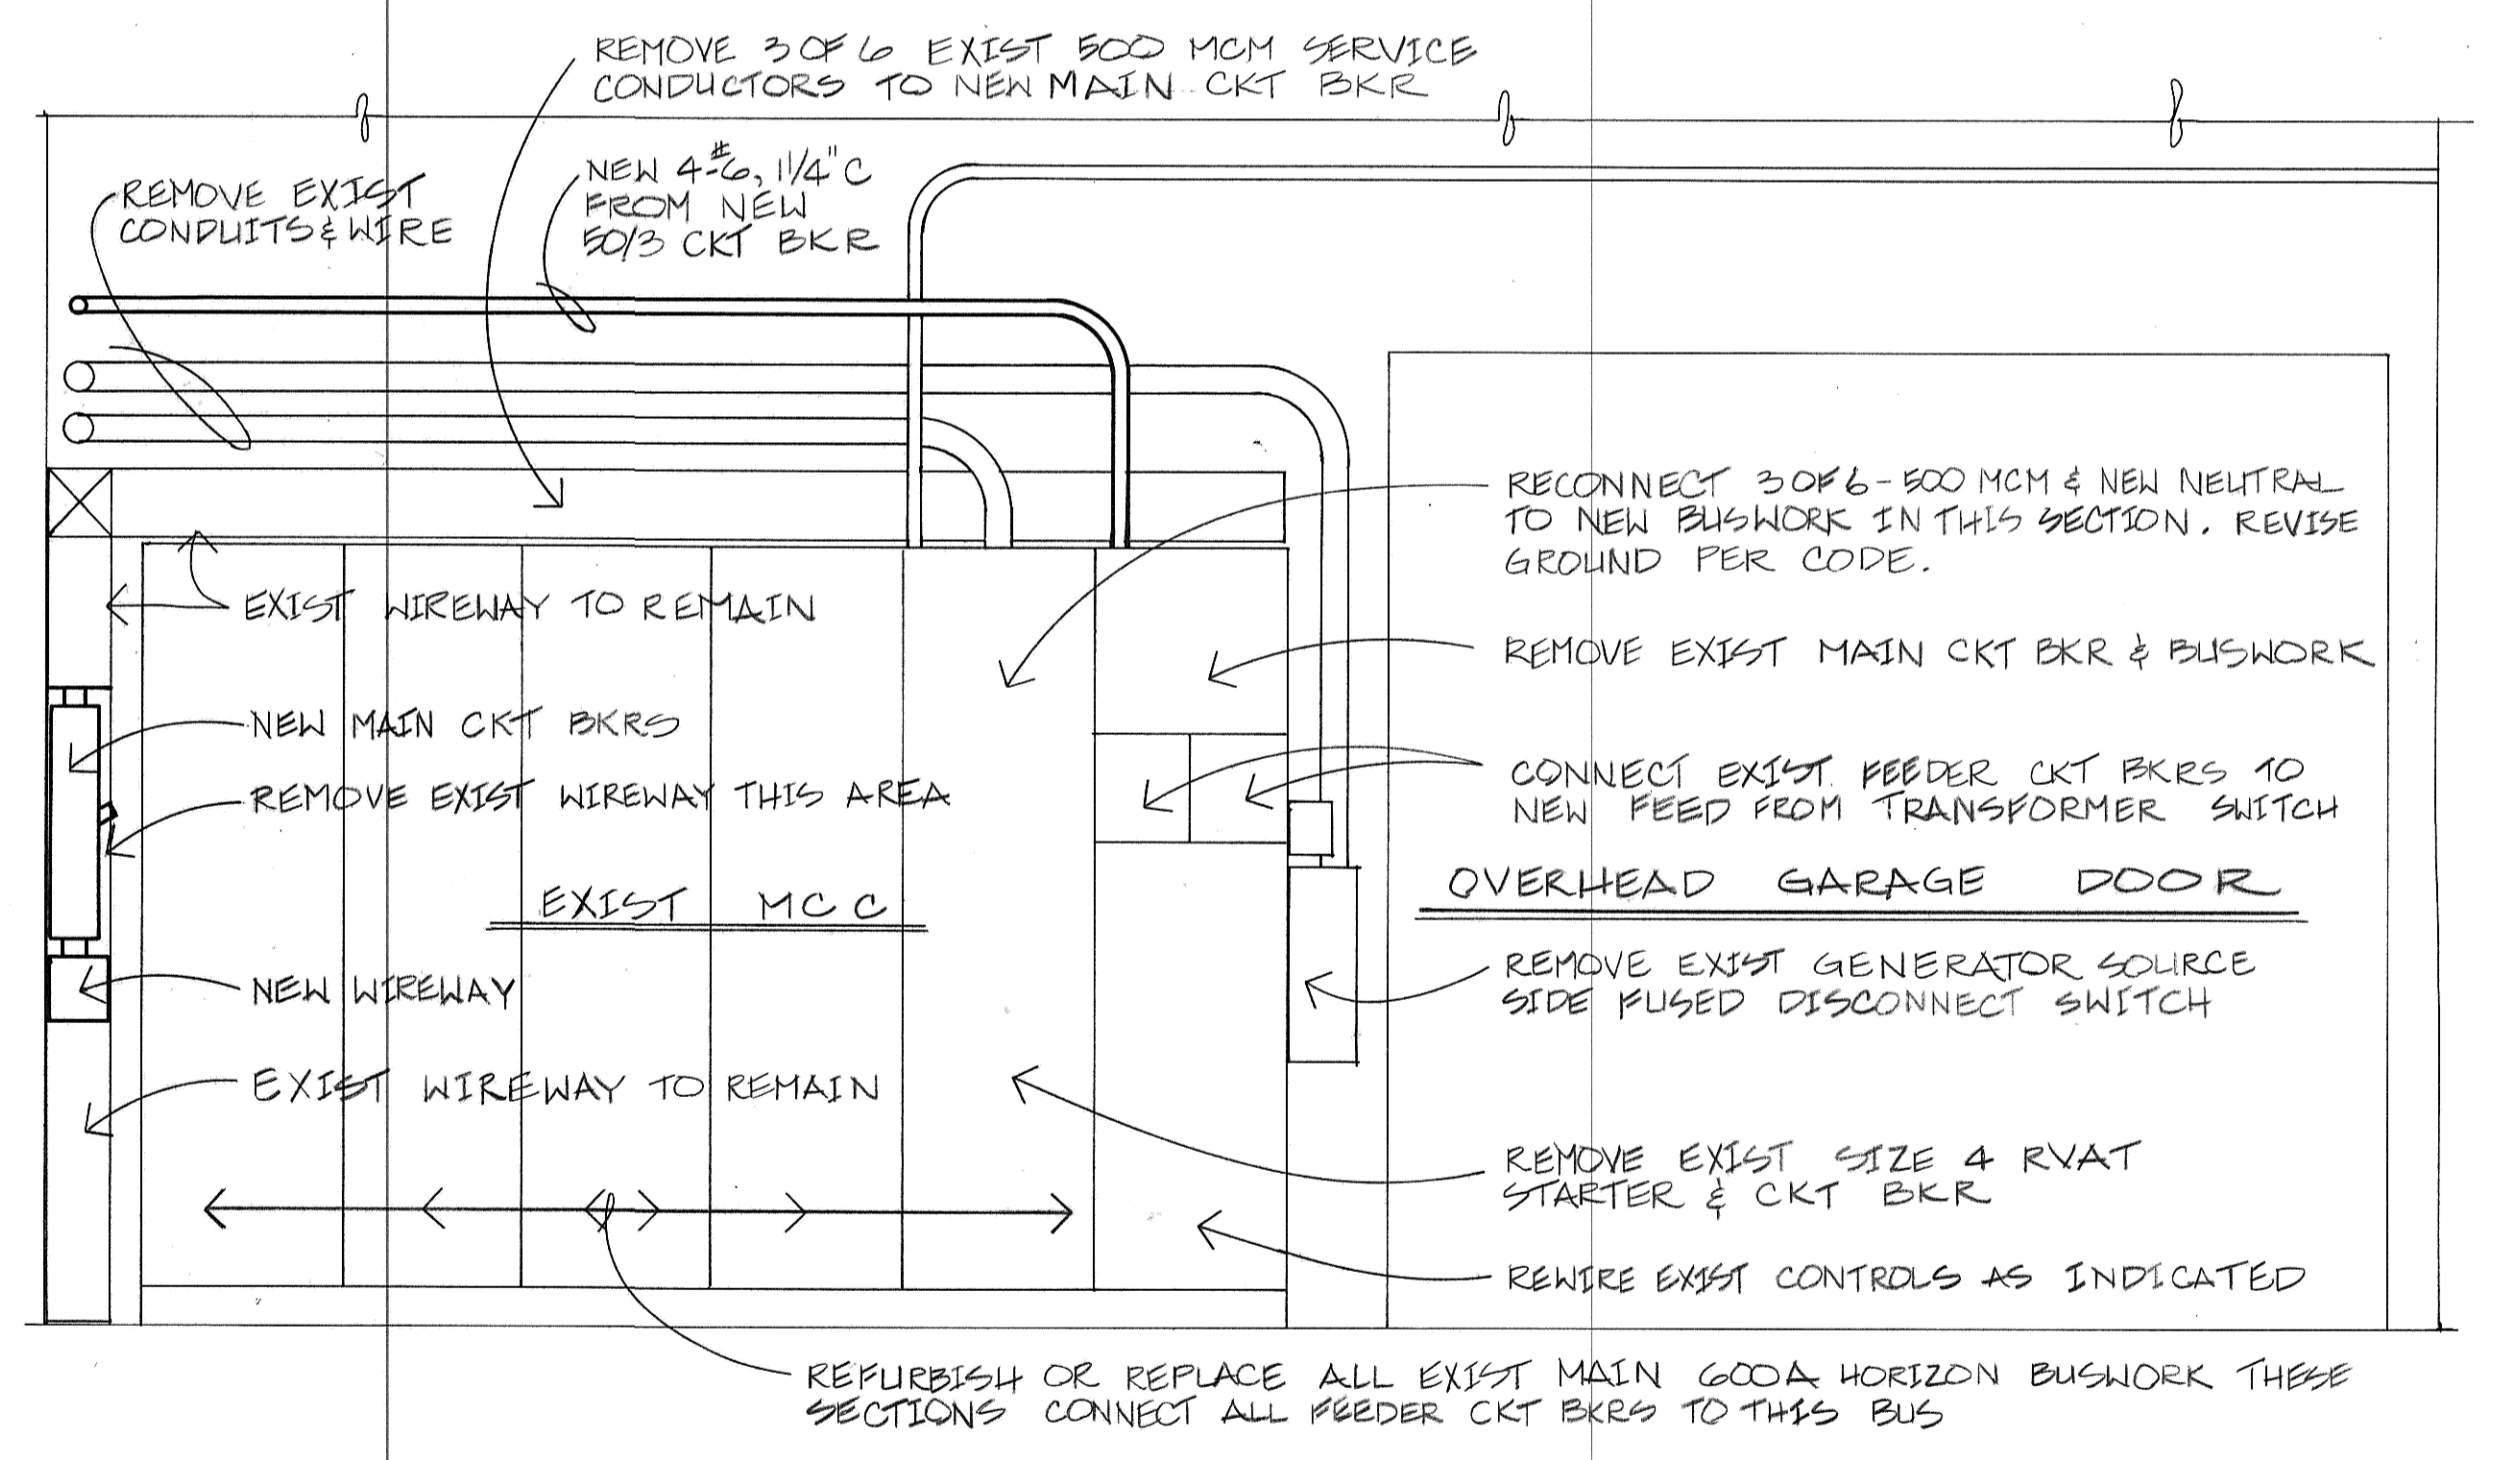

SECTION B-B PHASE III


REV.	DATE	DESCRIPTION	BY

MANDAN INTERCEPTOR 1984  
MANDAN, NORTH DAKOTA

MASTER PUMPING STATION  
EXISTING ELECTRICAL FLOOR PLAN

ULTEIG ENGINEERS, INC. CONSULTING ENGINEERS • ARCHITECT  
FARGO • BISMARCK • MINNEAPOLIS

DRAWN BY: *ERS* SCALE: AS SHOWN PROJECT NO. 4241.00  
CHECKED BY: *DH* DATE: MAY 1984  
APPROVED BY: *DH* SHEET E-2 of

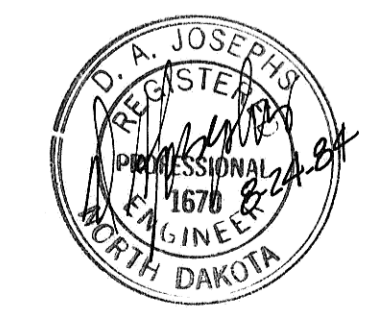

Record Drawing