


NORTH DAKOTA ASSOCIATION
OF
RURAL ELECTRIC COOPERATIVES
AND
NORTH CENTRAL DATA COOPERATIVE

SANITARY AND STORM SEWER IMPROVEMENTS
ASBUILT DRAWINGS

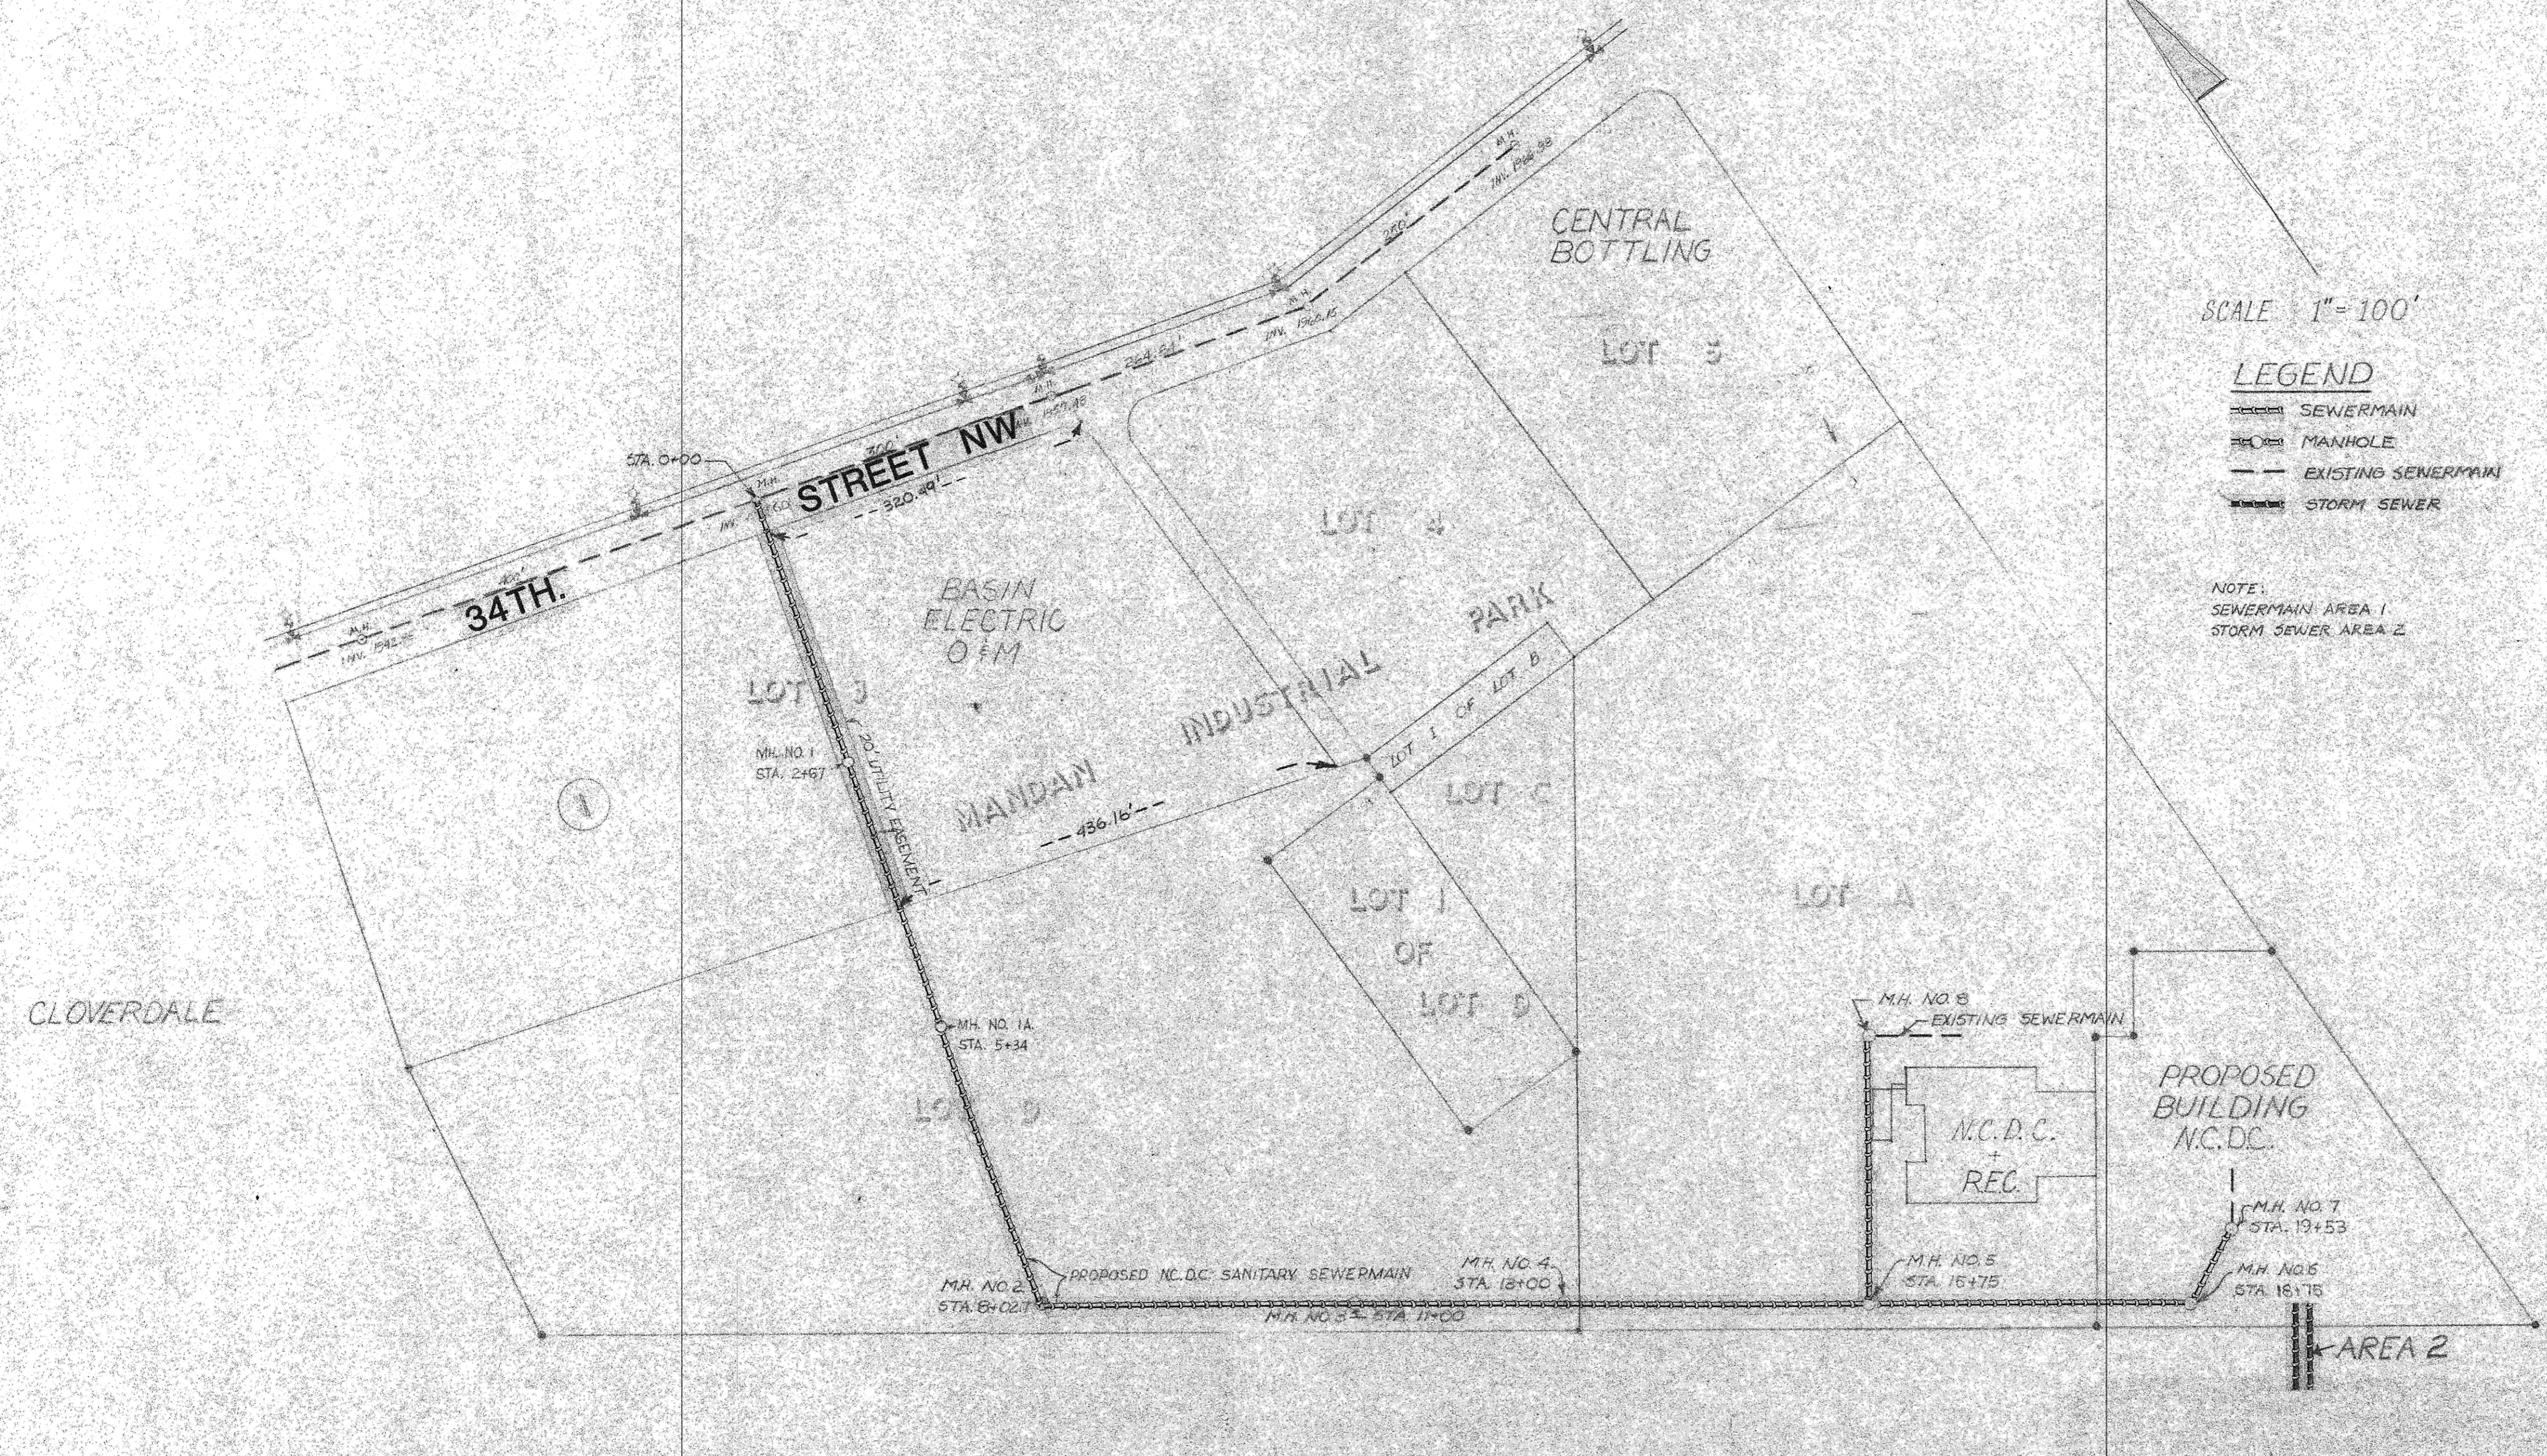

SCALE 1" = 100'


- LEGEND**
- SEWERMAIN
 - MANHOLE
 - EXISTING SEWERMAIN
 - STORM SEWER

NOTE:
SEWERMAIN AREA 1
STORM SEWER AREA 2

- INDEX**
- SHEET NO. 1. PROJECT LAYOUT
2. STA. 0+00 TO 12+00
SEWERMAIN PLANS AND PROFILE AREA 1
3. STA. 12+00 TO 19+78 AND
STA. 0+00 TO 2+383
SEWERMAIN PLAN AND PROFILE AREA 1
4. STORM SEWER PLAN AND PROFILE AREA 2
5. MANHOLE DETAILS

TECO PROJECT NO. 3157
CITY PROJECT NO. 82-9

APPROVED *Thomas Little* 9/22/82
THOMAS LITTLE PE.
CITY ENGINEER MANDAN, N.D.

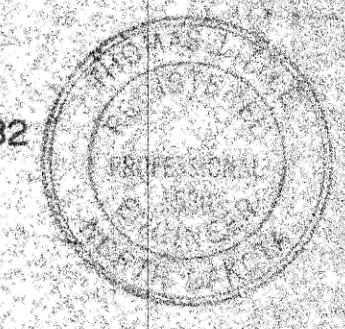

8

PROJECT LAYOUT

TECO TOMAN ENGINEERING COMPANY
CONSULTING CIVIL & ENVIRONMENTAL ENGINEERS
P.O. BOX 708 • 906 2ND ST. N.W.
MANDAN, NORTH DAKOTA 58542 • 701-663-8483

AUGUST 1982

SHEET NO. 1 OF 5 SHEETS

P 82-9